
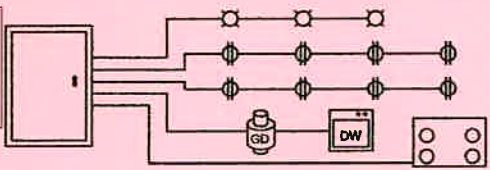


A10-Kitchen & Bath Remodel Electrical Plan

THIS DRAWING DEPICTS MINIMUM CODE REQUIREMENTS PER CRC INFORMATION IS FOR REFERENCE ONLY AND IS NOT A SUBSTITUTE FOR ACCURATE DRAWINGS PREPARED FOR EACH PROPOSED CONSTRUCTION PROJECT.

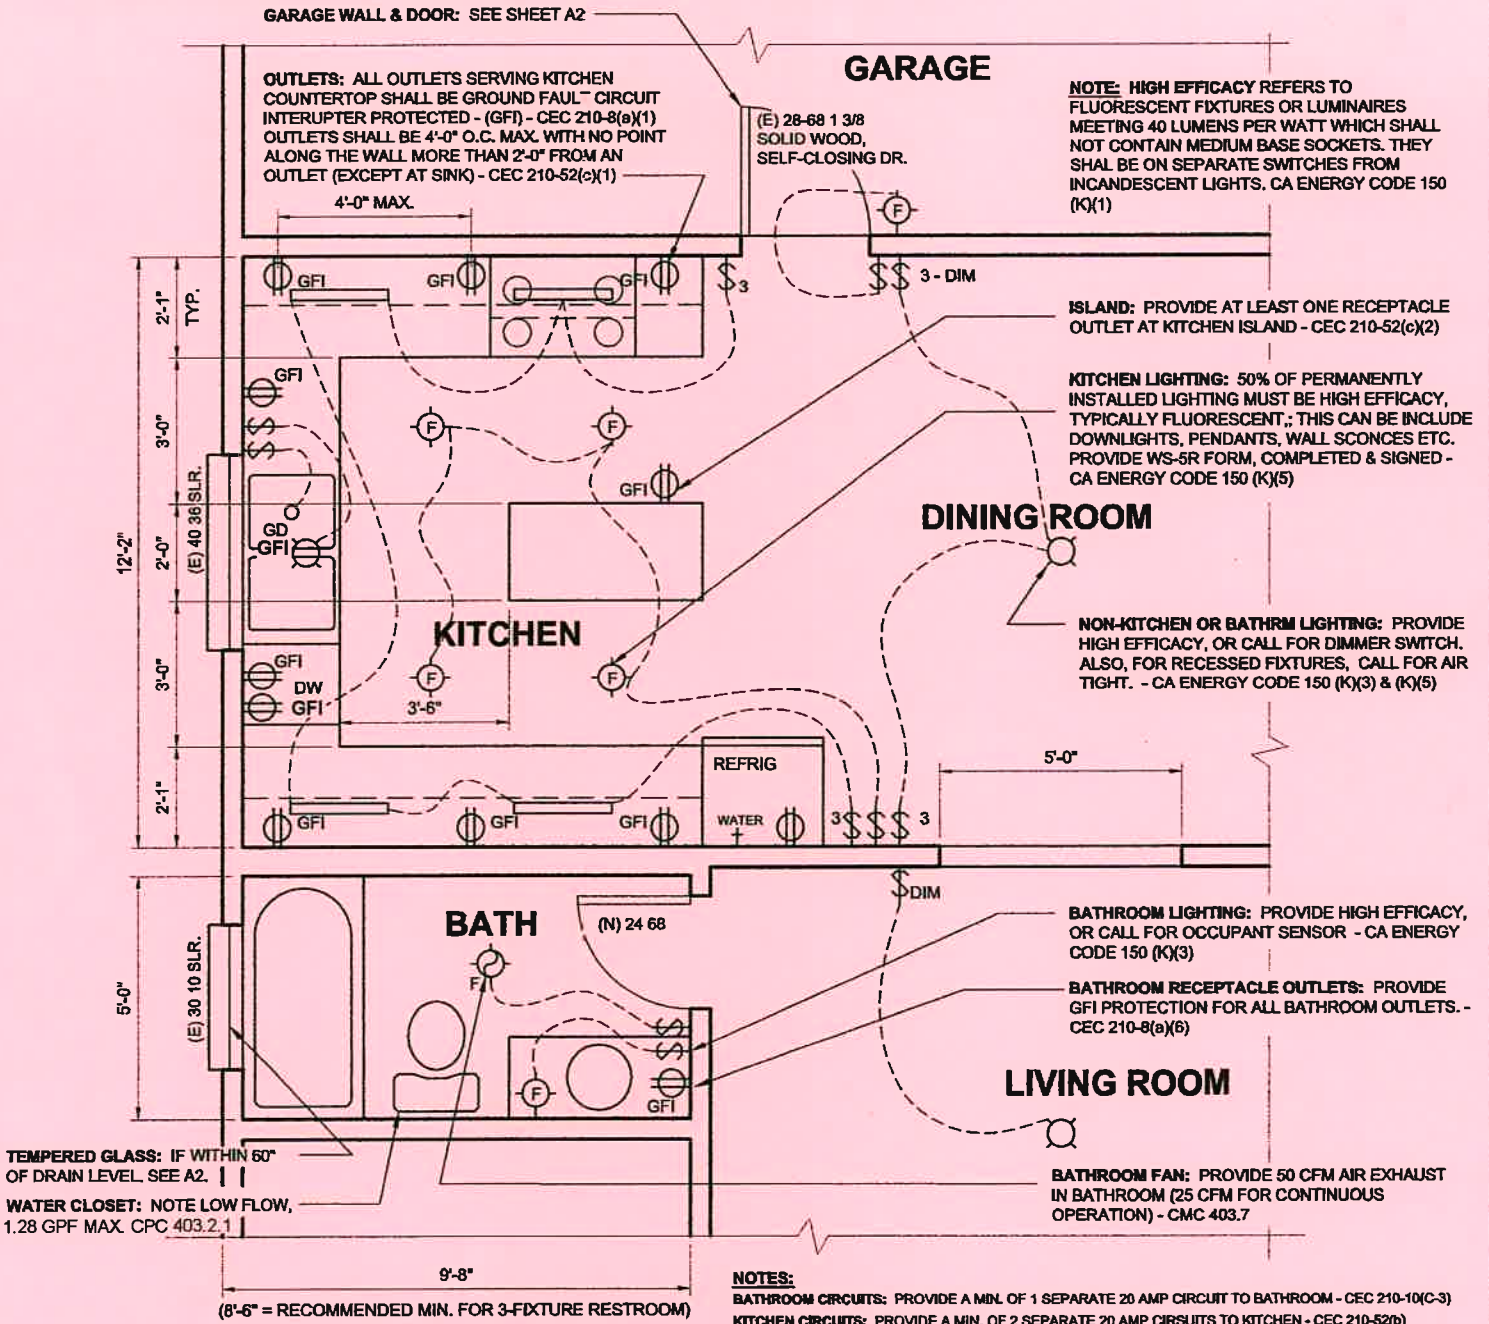

Provide Title Block. Leave margin on all sides.

This scale is for example only. Use 1/8" or 1/4" = 1'-0". Typical min. sheet size is 11" x 17" (8 1/2" X 11" for small projects.)

NAME, ADDRESS AND PHONE NO. OF DESIGNER XXX XXX XXX XXX XXX XXX XXX XXX	EXAMPLE RESIDENCE	PLAN	SCALE: 1/4" = 1'-0" DATE:
WET SIGNATURE OF DESIGNER ON EACH SHEET (AND PROFESSIONAL STAMP IF APPLICABLE)			SAMPLE DRAWING